


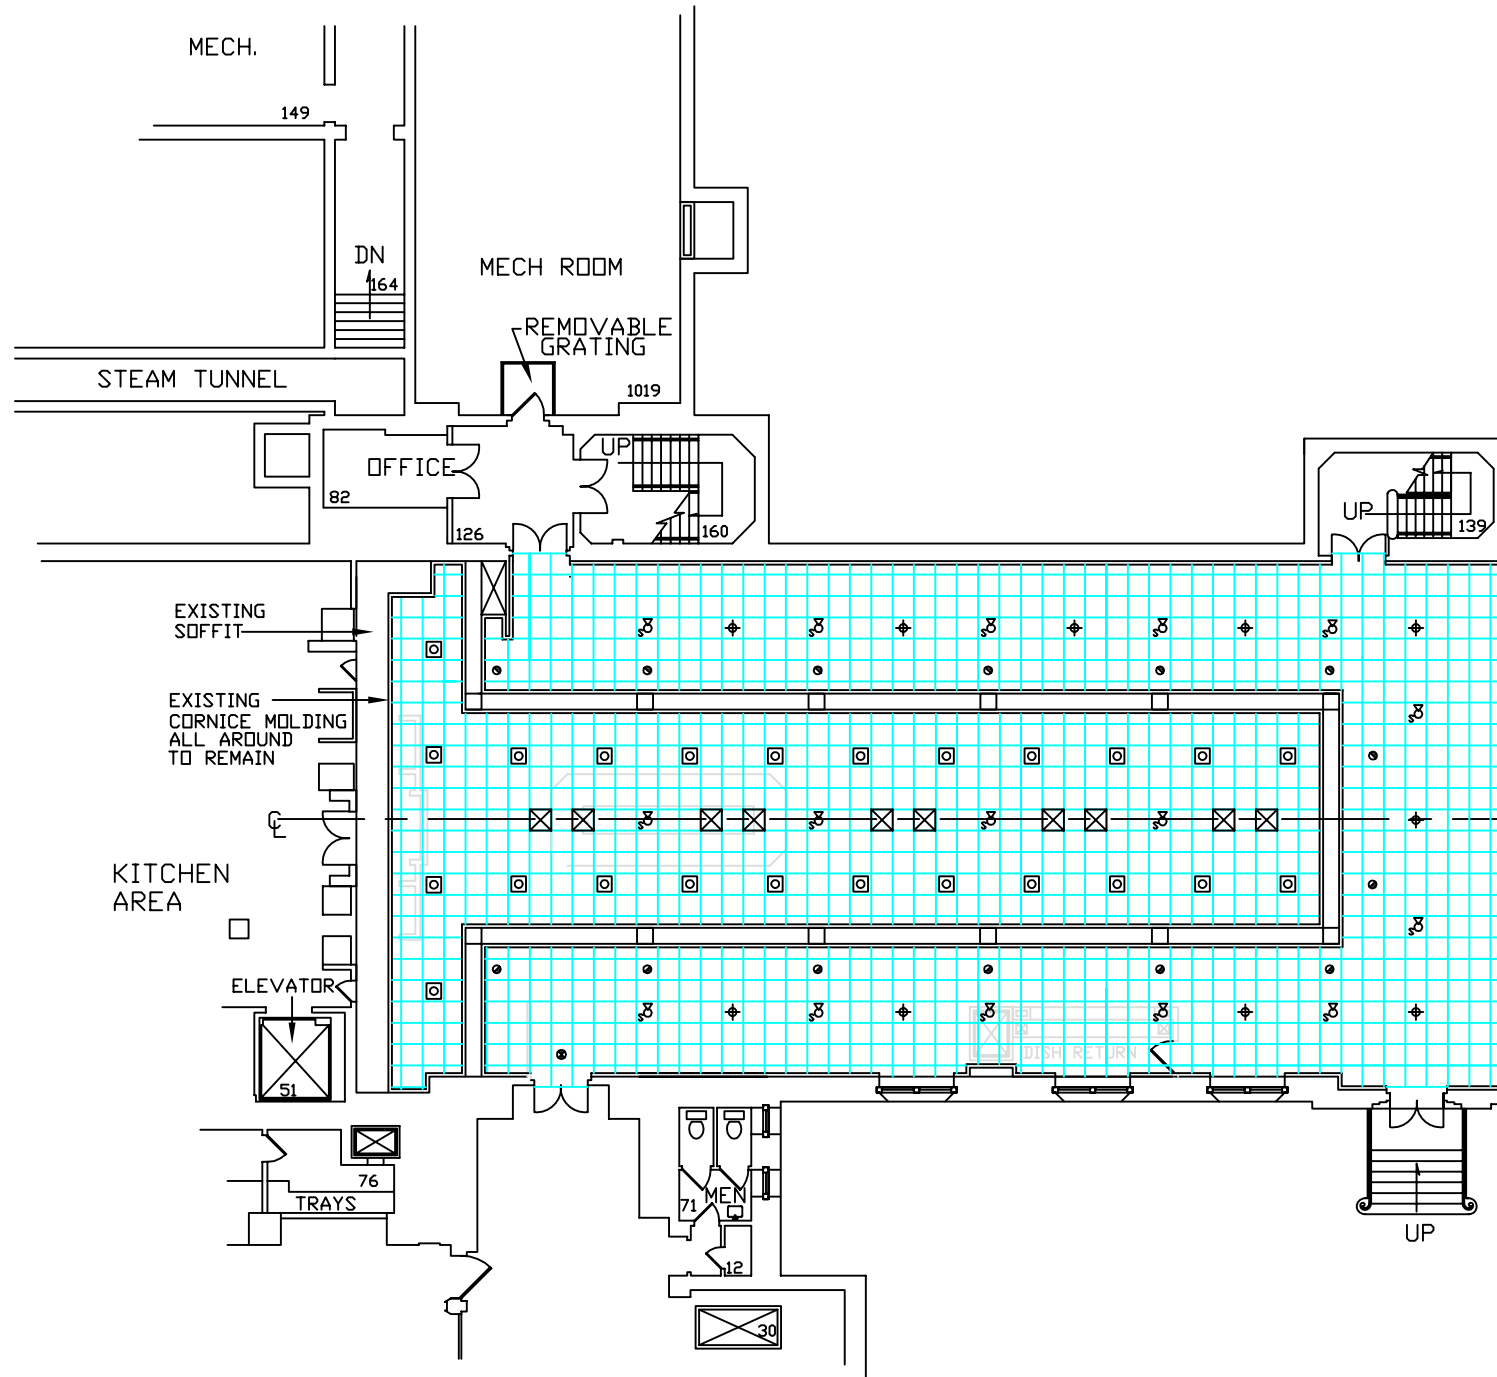

LEGEND

- 2' X 2' CEILING GRID
- NEW 2' X 2' DIFFUSERS
- EXISTING CHANDELIERS TO BE REINSTALLED
- REINSTALL EXISTING SPEAKERS
- REINSTALL EXISTING EMERGENCY EXIT LIGHTS
- REINSTALL EXISTING RECESSED EMERGENCY FIXTURES
- NEW RECESSED COMPACT FLOURESCENTS TO REPLACE EXISTING FIXTURES

UNIVERSITY CENTER
CORT DINING
REFLECTED CEILING PLAN

Scale: 3/32" = 1'
Date: 6/18/2003